


3D VIEW - 1

LESS THAN 30 DAYS OUT




MORE THAN 30 DAYS OUT



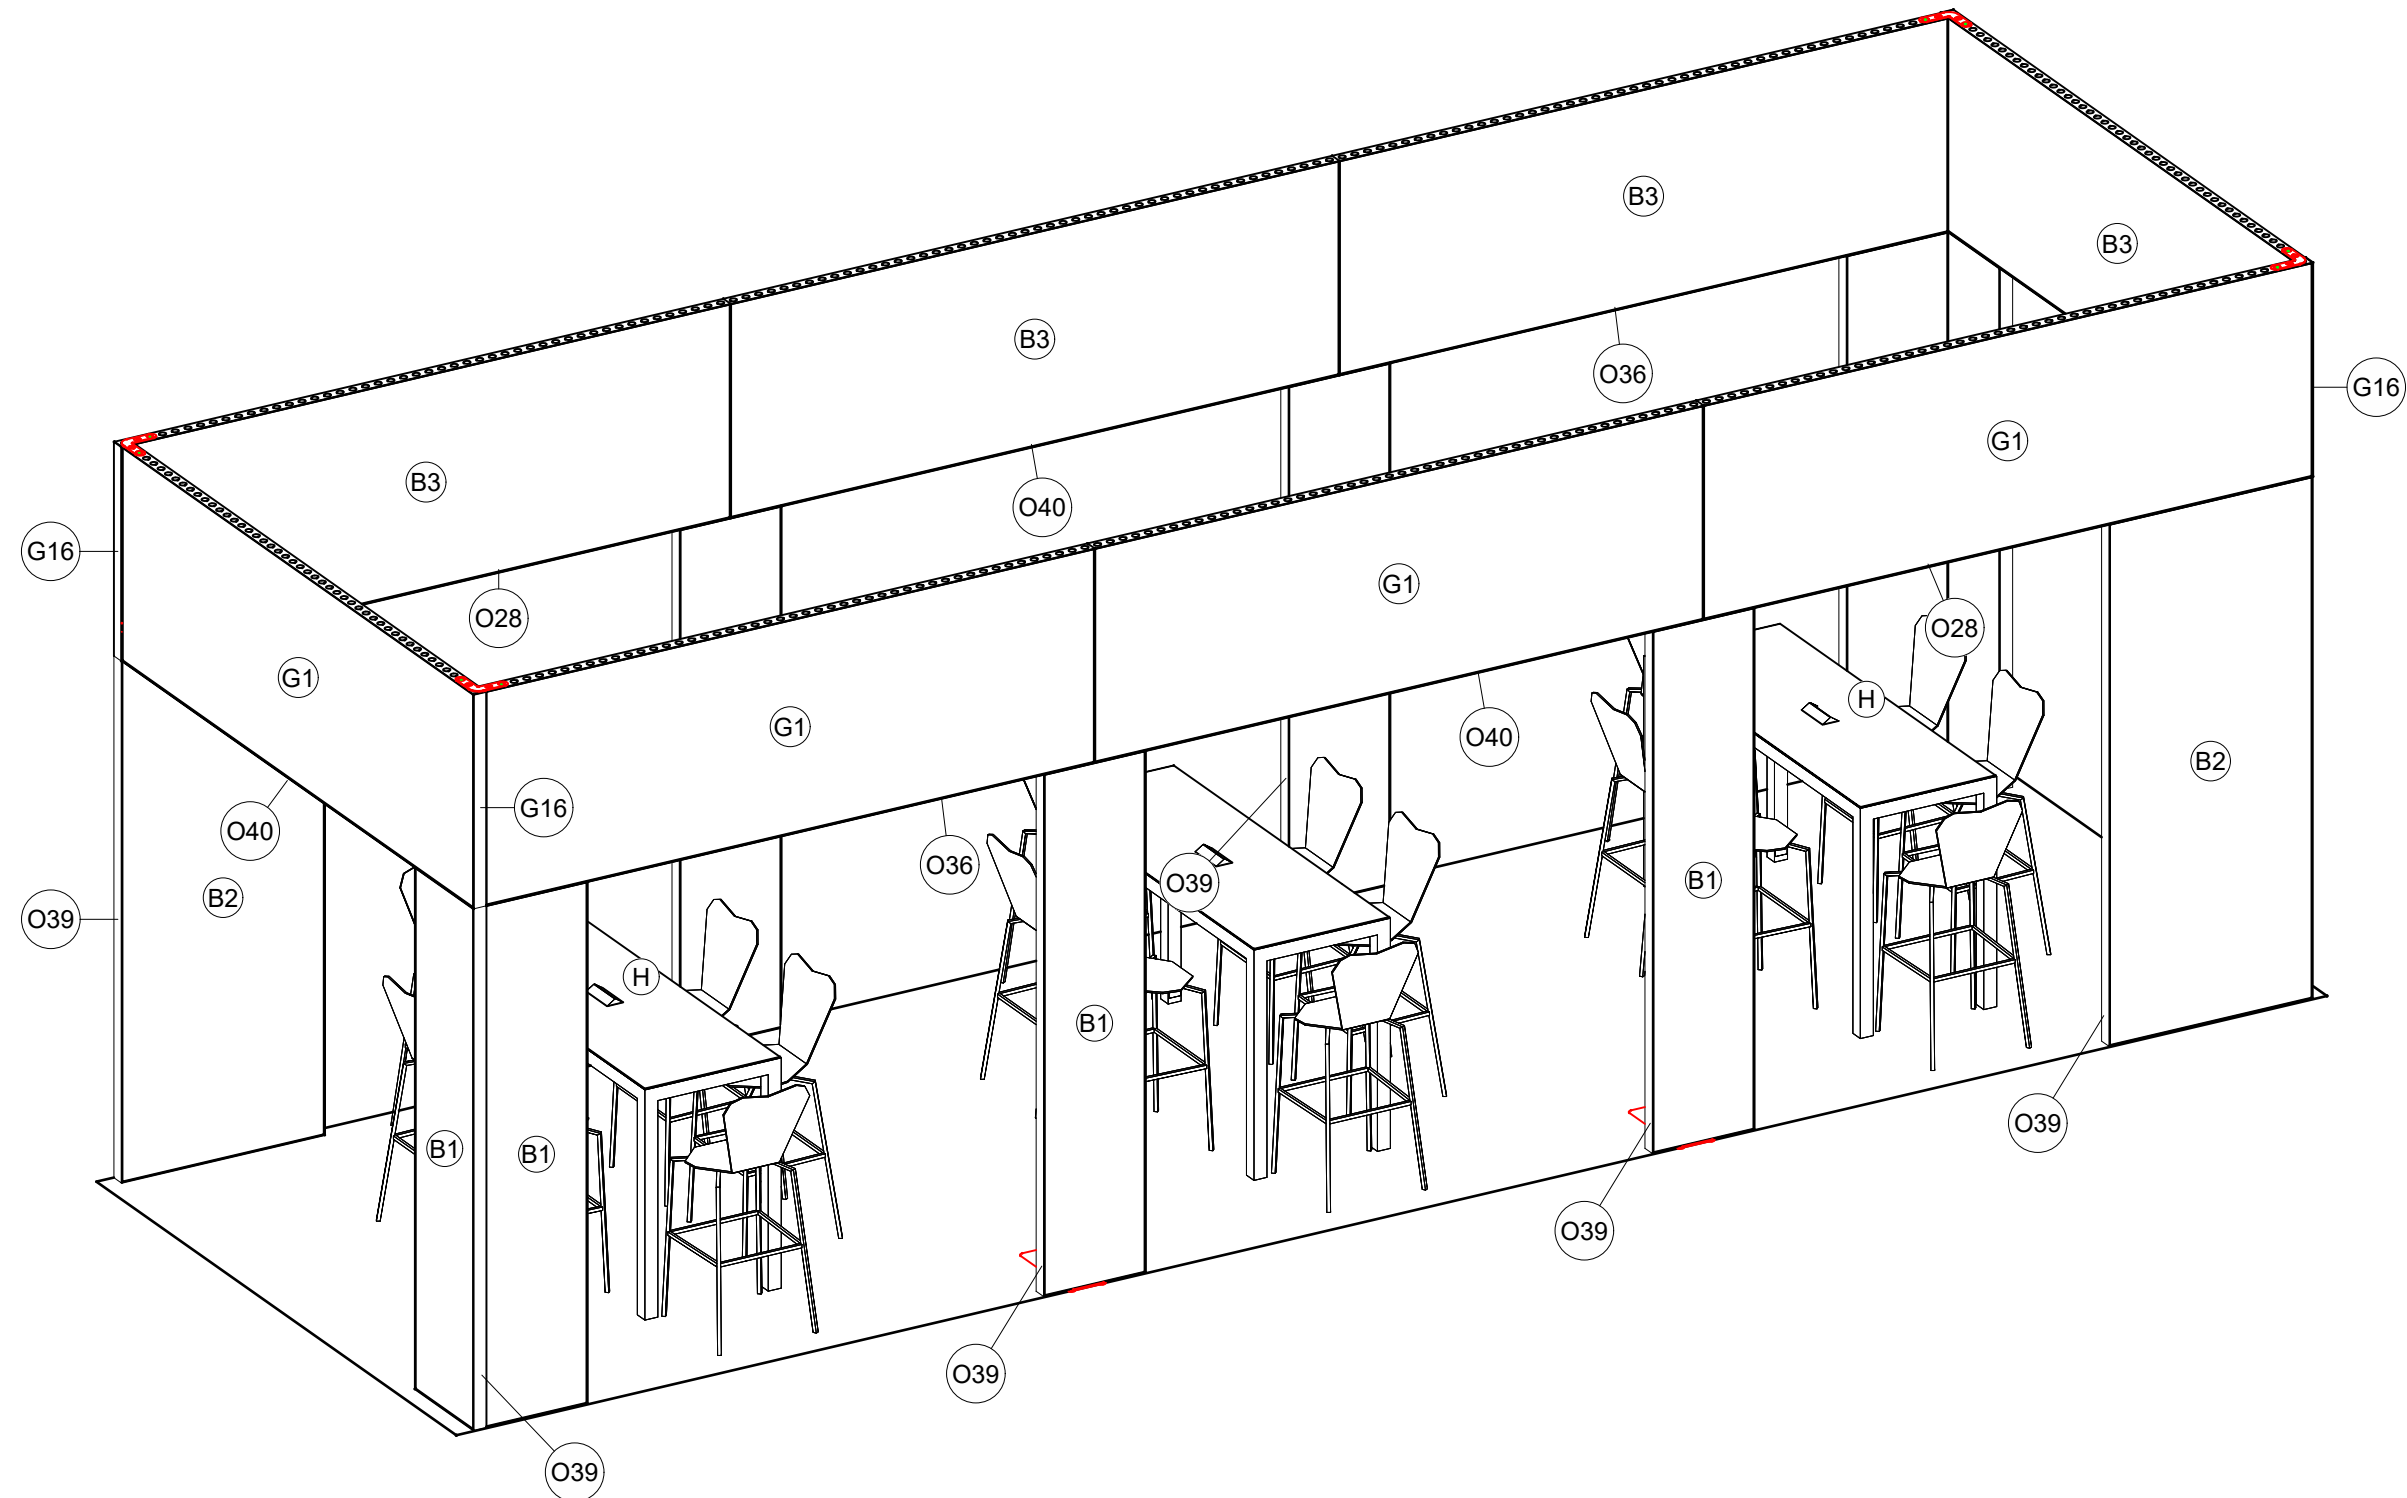


3D VIEW - 2

FRONT ELEVATION Scale: 3/8" = 1'-0"

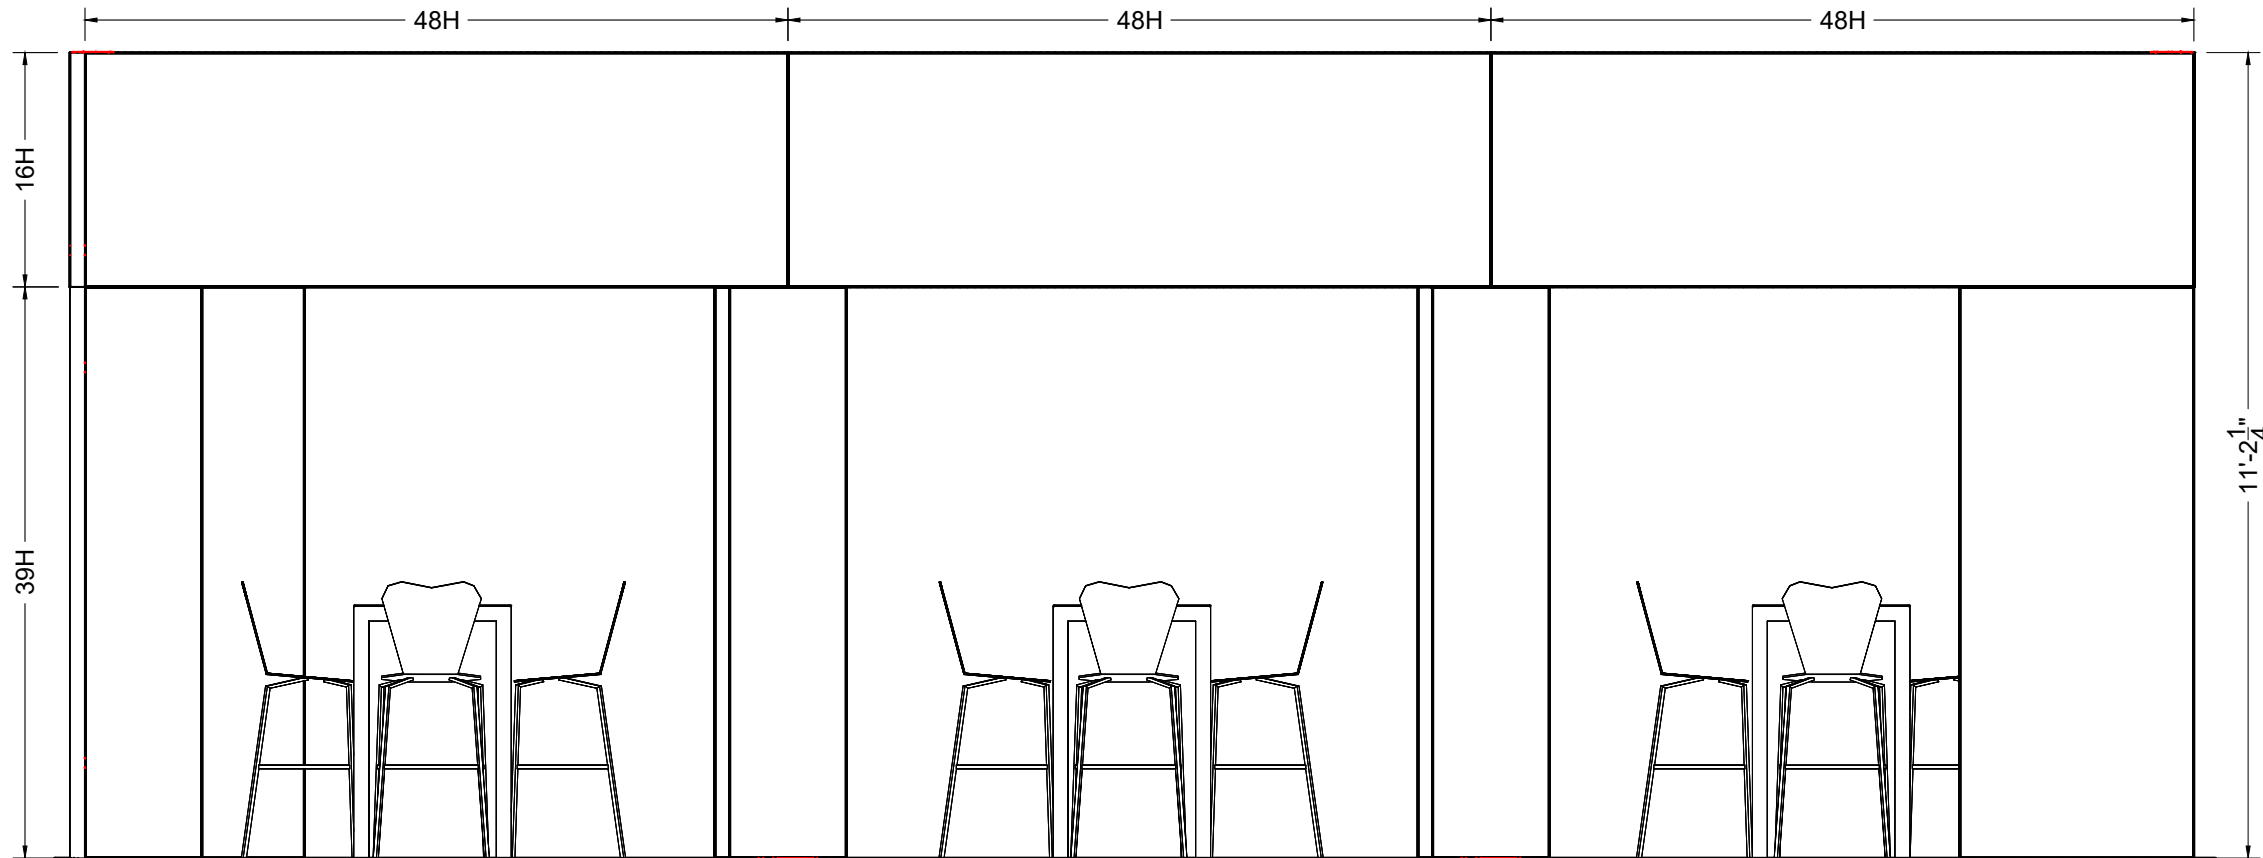

PLAN VIEW Scale: 3/8" = 1'-0"

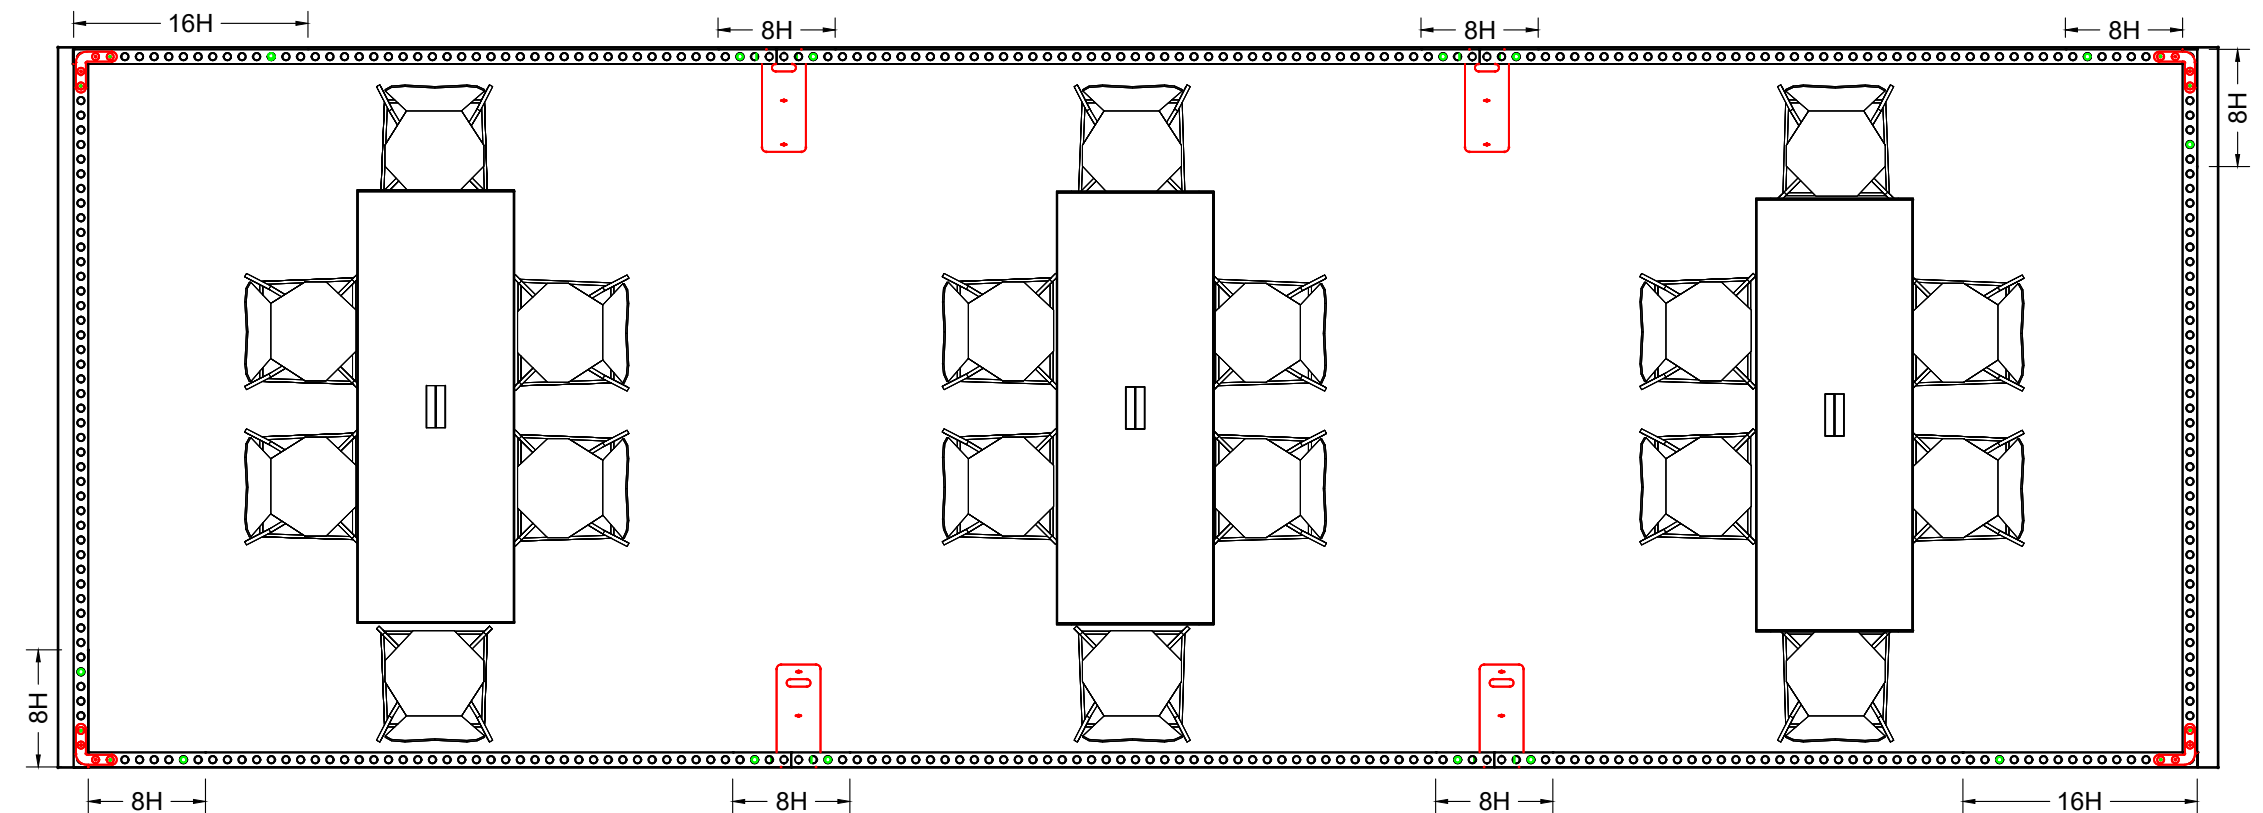

Qty:9



PIECE COUNT FOR 1 UNIT

FULL PULL LIST


I.D.	Qty	Type	Size	Area (SqFt)	Part Number	Description	Material	Color	Notes	Low Inv.
	8	FLEX Frame-Straight	19-1/2" x 95-3/16"		60400028	Straight Frame 08 Hole x 39 Hole	Aluminum	Silver	SF08390001	
	8	FLEX Frame-Straight	39-1/16" x 117-3/16"		60400044	Straight Frame 16 Hole x 48 Hole	Aluminum	Silver	SF16480001	
	2	FLEX Frame-Straight	39-1/16" x 95-3/16"		60400043	Straight Frame 16 Hole x 39 Hole	Aluminum	Silver	SF16390001	
BS	4	FLEX Acc-Base Plate	7-5/16" x 17-1/16" x 0-7/16"		60440081	Base plate small	Steel	Silver		
C20	8	FLEX Acc-Pin Plate	Standard		60440055	Stainless steel 90° connector base	Steel	Stainless	CO901280222INOX	
P2	4	FLEX Acc-Pin Plate	Standard		60440060	4 Pin 90	Steel	Chrome	CO901280341C	
C1	28	FLEX Part-Connector	Standard		60440043	Manual Clamp Connector	Aluminum	Silver	CO90120250132POM	
C10	28	FLEX Part-Connector	Standard		60440047	Manual M8 Pin Connector	Aluminum	Silver	CO90120480066MKII	
B1	16	Flex Insert	19-1/4" x 94-15/16"		60160035	Flex Insert [8x39 Hole]	PVC 3MM	Black	w/ Female Velcro	
B2	4	Flex Insert	38-3/4" x 94-15/16"		60160051	Flex Insert [16x39 Hole]	PVC 3MM	Black	w/ Female Velcro	
B3	8	Flex Insert	38-3/4" x 116-7/8"		60160052	Flex Insert [16x48 Hole]	PVC 3MM	Black	w/ Female Velcro	
O28	2	Overlay Panel	2-7/16" x 68"	1.2		Cover Profile 28 Hole	PVC 3MM	White		
O36	2	Overlay Panel	2-7/16" x 87-1/2"	1.5		Cover Profile 36 Hole	PVC 3MM	White		
O39	18	Overlay Panel	2-7/16" x 95-3/16"	1.6		Cover Profile 39 Hole	PVC 3MM	White		
O40	4	Overlay Panel	2-7/16" x 97-3/8"	1.6		Cover Profile 40 Hole	PVC 3MM	White		
G1	8	Flex Graphic Insert	116-7/8" x 38-3/4"	31.5	60160052	Flex Insert [16x48 Hole]	PVC 3MM	Graphic	w/ Female Velcro	
G16	4	Overlay Graphic Panel	2-7/16" x 39-1/16"	0.7		Cover Profile 16 Hole	PVC 3MM	Graphic		
H	3	Overlay Graphic Panel	71 3/4" x 26"	13.0		Overlay Graphic Panel/CNC	Low Tac Cling	Graphic		
	3	Furniture	72-1/4" x 26-1/4" x 42"			Ventura Powered Communal Bar Table	STD	White		



UTILITIES LEGEND

QTY	DESCRIPTION
??	A - 120V, 500W (5 AMP)
??	B - 120V, 1000W (10 AMP)
??	C - 120V, 1500W (15 AMP)
??	D - 120V, 2000W (20 AMP)
??	E - 120V, 2000W (20 AMP) 24 HR.
??	A - 208V, 60A
??	B - 208V, 100A
??	C - 480V, 3PH, 200A
??	- ELECTRICAL CORDS
??	- RECEPTACLE POINT
??	- MULTISTRIP
??	- QUADBOX
??	- OVERHEAD PAR CAN

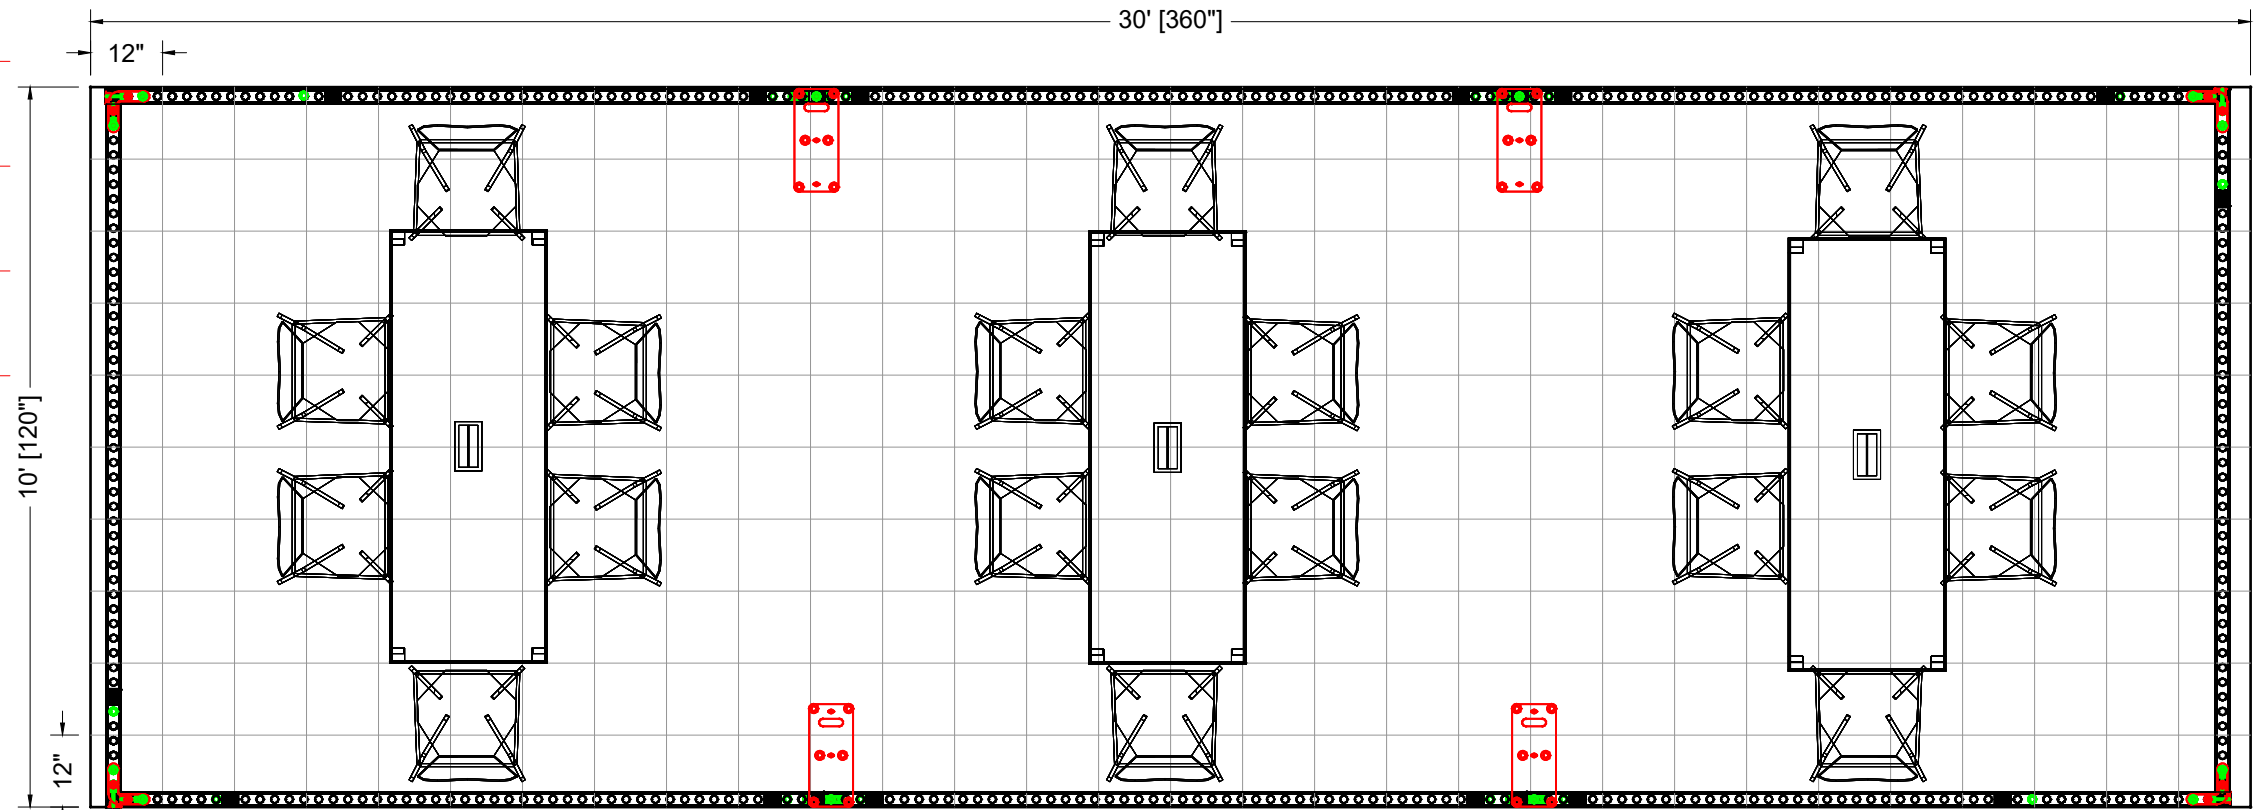 

ELECTRICAL LAYOUT
Scale: 3/8" = 1'-0"

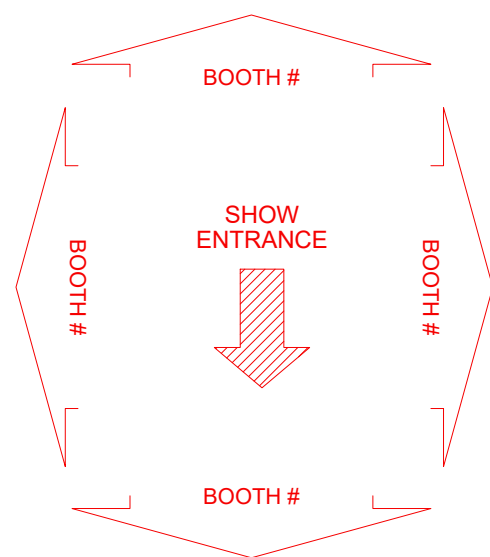

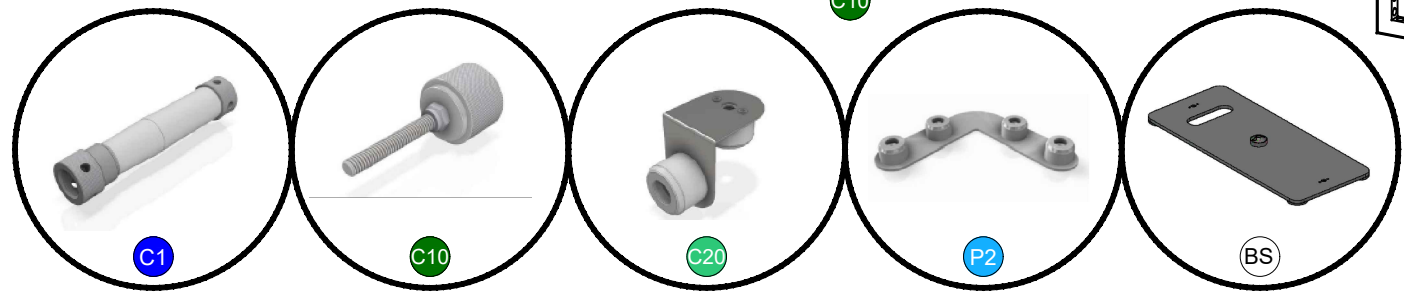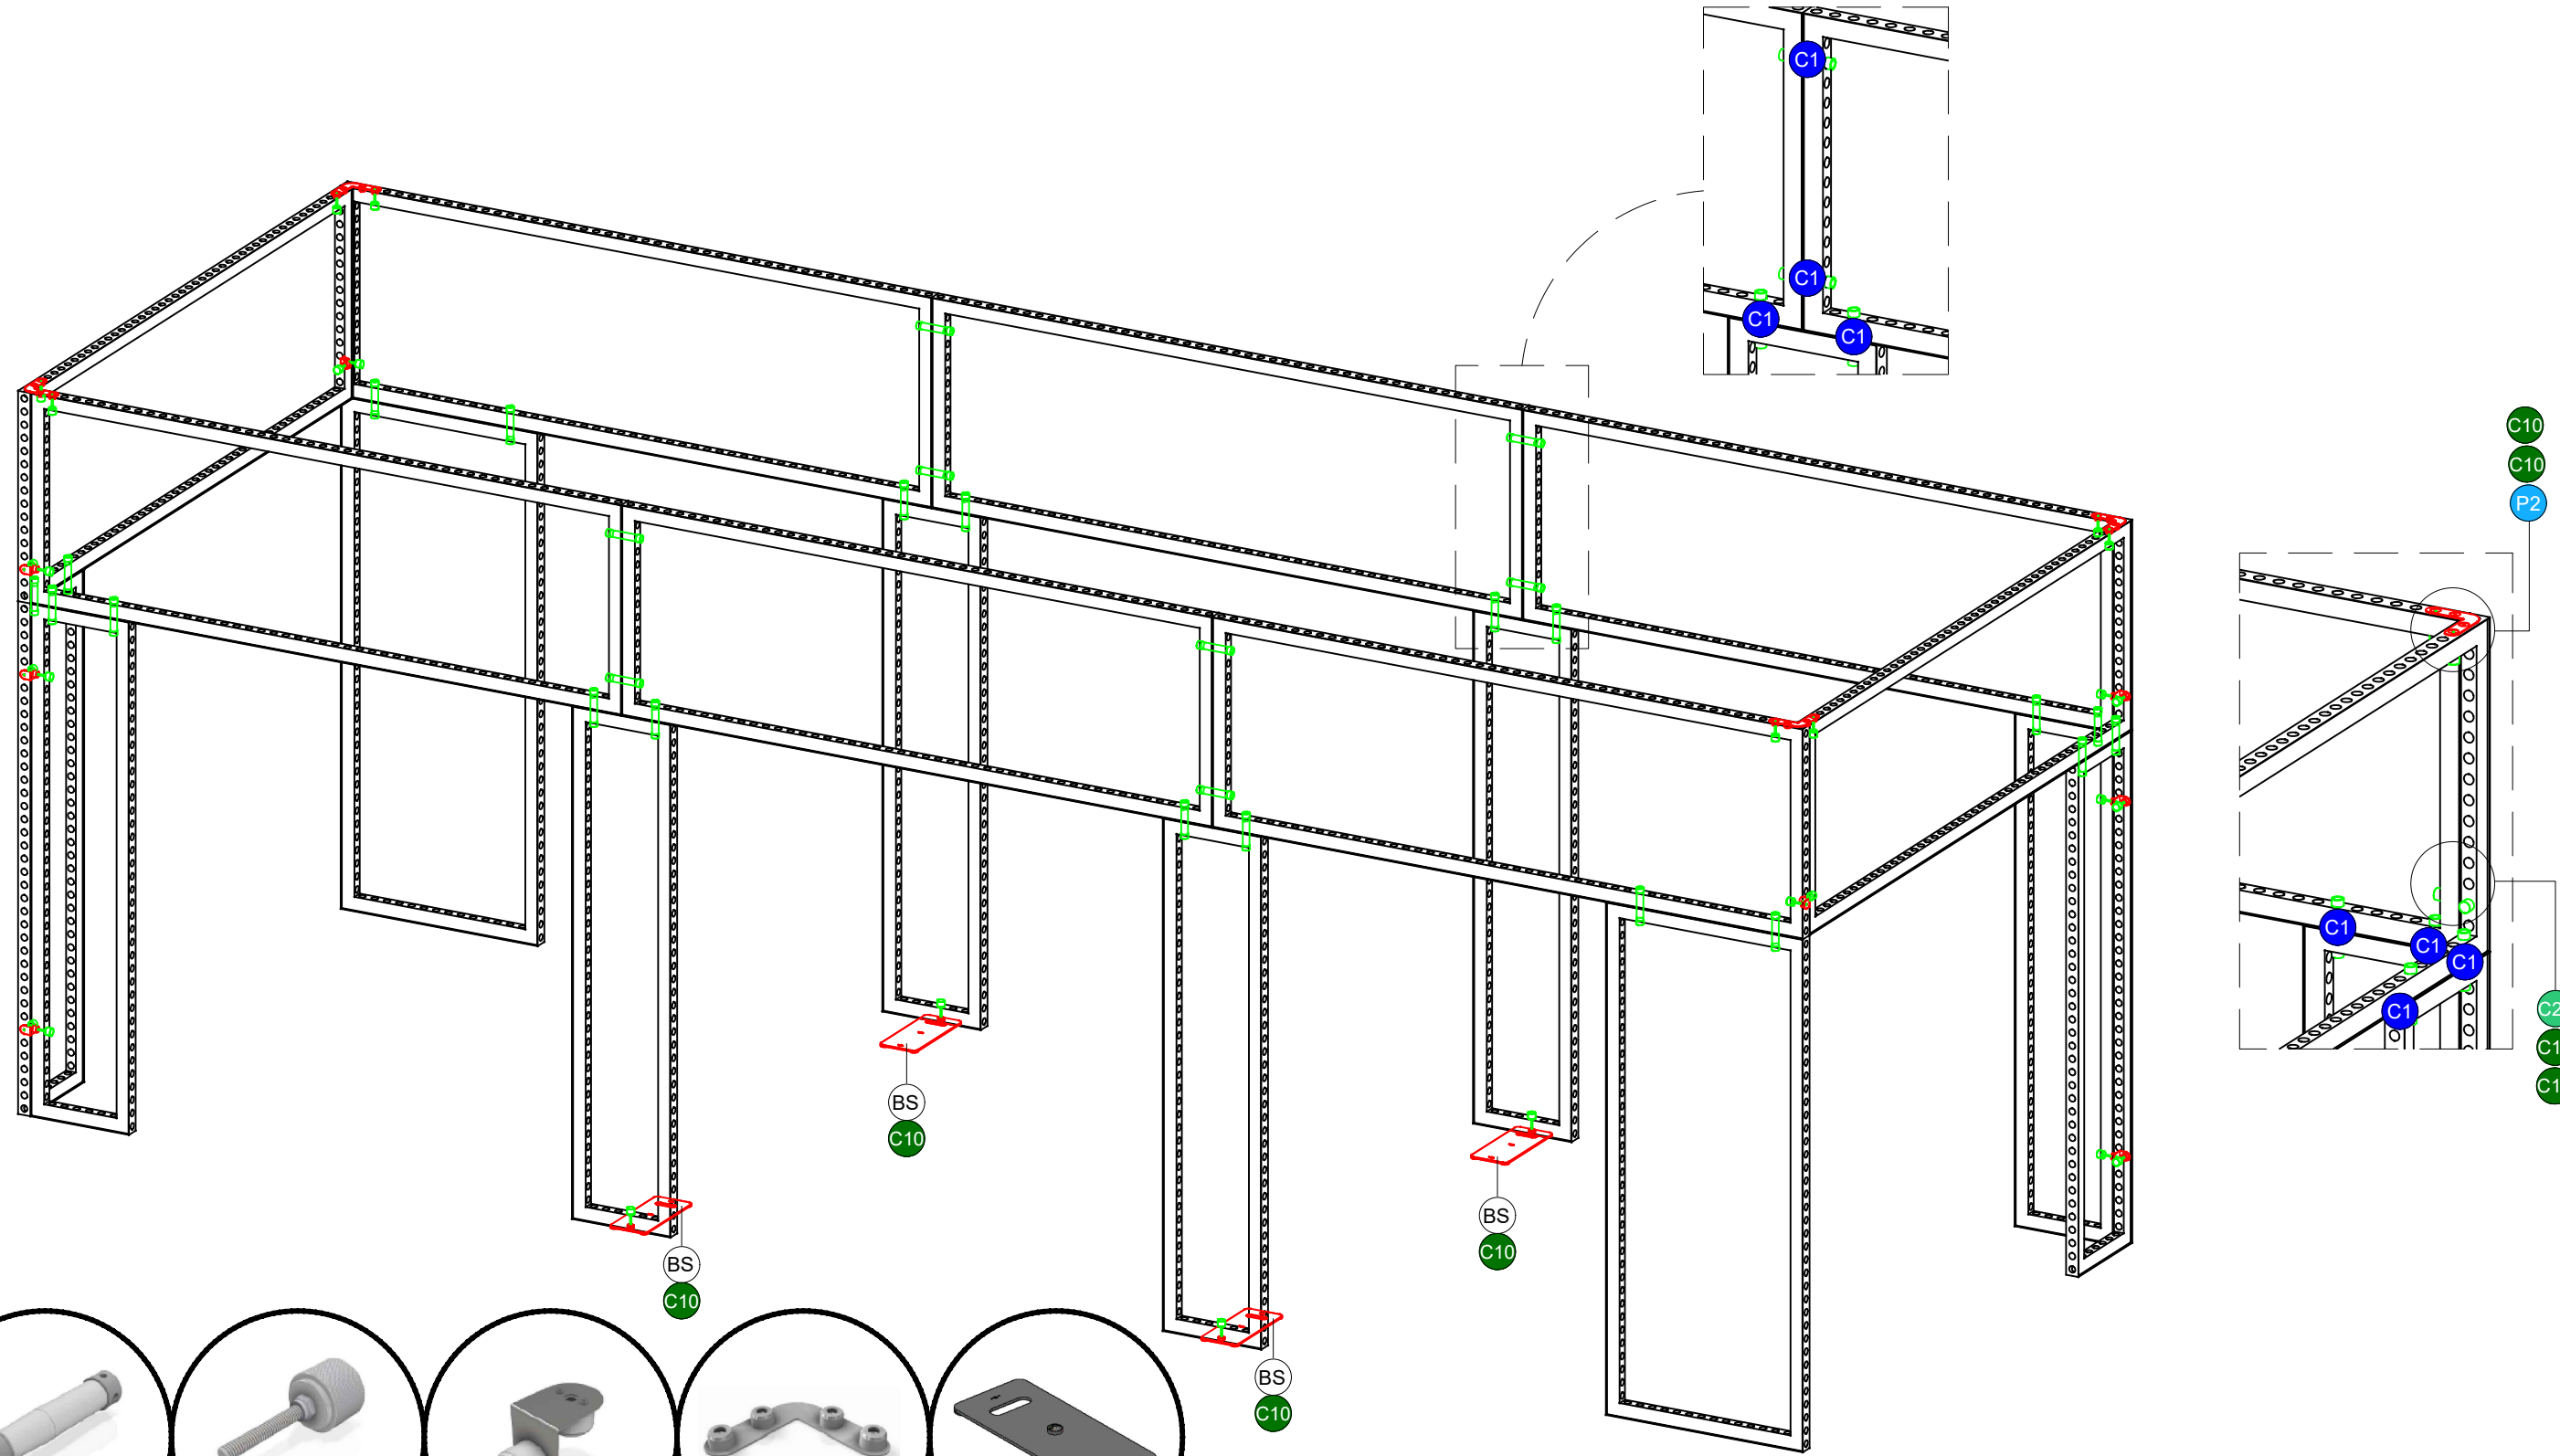

ORDERED BY:

ORDER DATE:


DUE DATE:

14

000000

CNC PAGE

MIS METAL

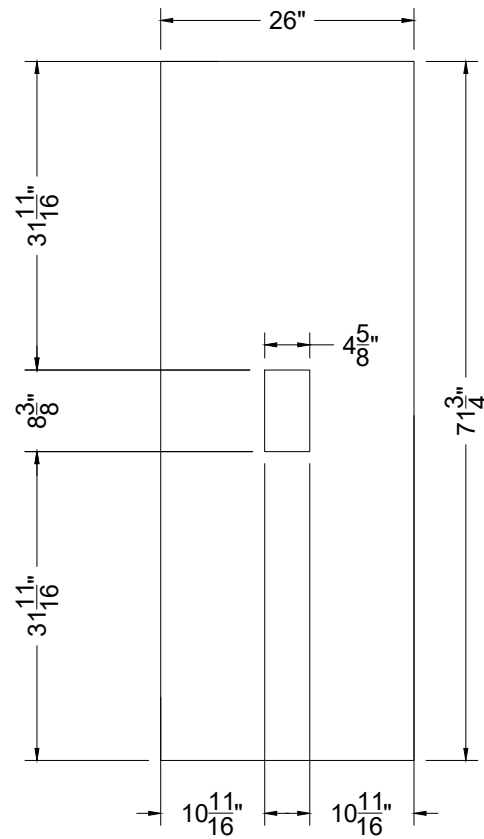

NAME:
 MATERIAL:
 NOTES:
 QTY:
 NEED TO CUT: